

LEGEND

EXISTING WATER	---
EXISTING STORMWATER	---
EXISTING SEWER	---
SEWER MANHOLES	○ S MH
STORM WATER MANHOLES	○ SW MH
STORM WATER CATCH PIT	⊗ SW
BOUNDARY LINE	---
BUILDING LINE	---

CONCEPT

Rev	Date	Description of changes	By
a	2022-06-30	ISSUED FOR INFORMATION	MP
b	2022-07-06	REVISED FOR REVIEW	MP
c	2022-07-26	REVISED AS PER COMMENTS RECEIVED	MP
d	2022-07-28	REVISED AS PER COMMENTS RECEIVED	MP

REVISIONS

Client

The Bus Factory
No.3 President Street
Newtown
Johannesburg
TEL: +27 11 688 7851
FAX: +27 11 688 7899

Consultant

P O BOX 35703
MENLO PARK
0102
TEL: +27-12-368-1850
FAX: +27-12-348-4738

APPROVED PRARCH 30447969

THE MASTER HELD AT DELTA BUILT ENVIRONMENT
CONSULTANTS BEARS THE ORIGINAL SIGNATURE OF APPROVAL

SHAKIRA BENADIE-MARAIS
SIGNATURE NAME DATE

Project

JDA SOUTH HILLS CLINIC

Project Description

SOUTH HILLS CLINIC

Drawing Title


SITE PLAN

Drawing Units MILLIMETERS	Drawing Size A1
------------------------------	--------------------

Date JUNE 2022	Scale 1 : 500	Designed by SBM
-------------------	------------------	--------------------

Checked by MP	Drawn by SBM	Approved by MP
------------------	-----------------	-------------------

Drawing No. P22002-CC-06-ARC- 099	Rev. d
--------------------------------------	-----------

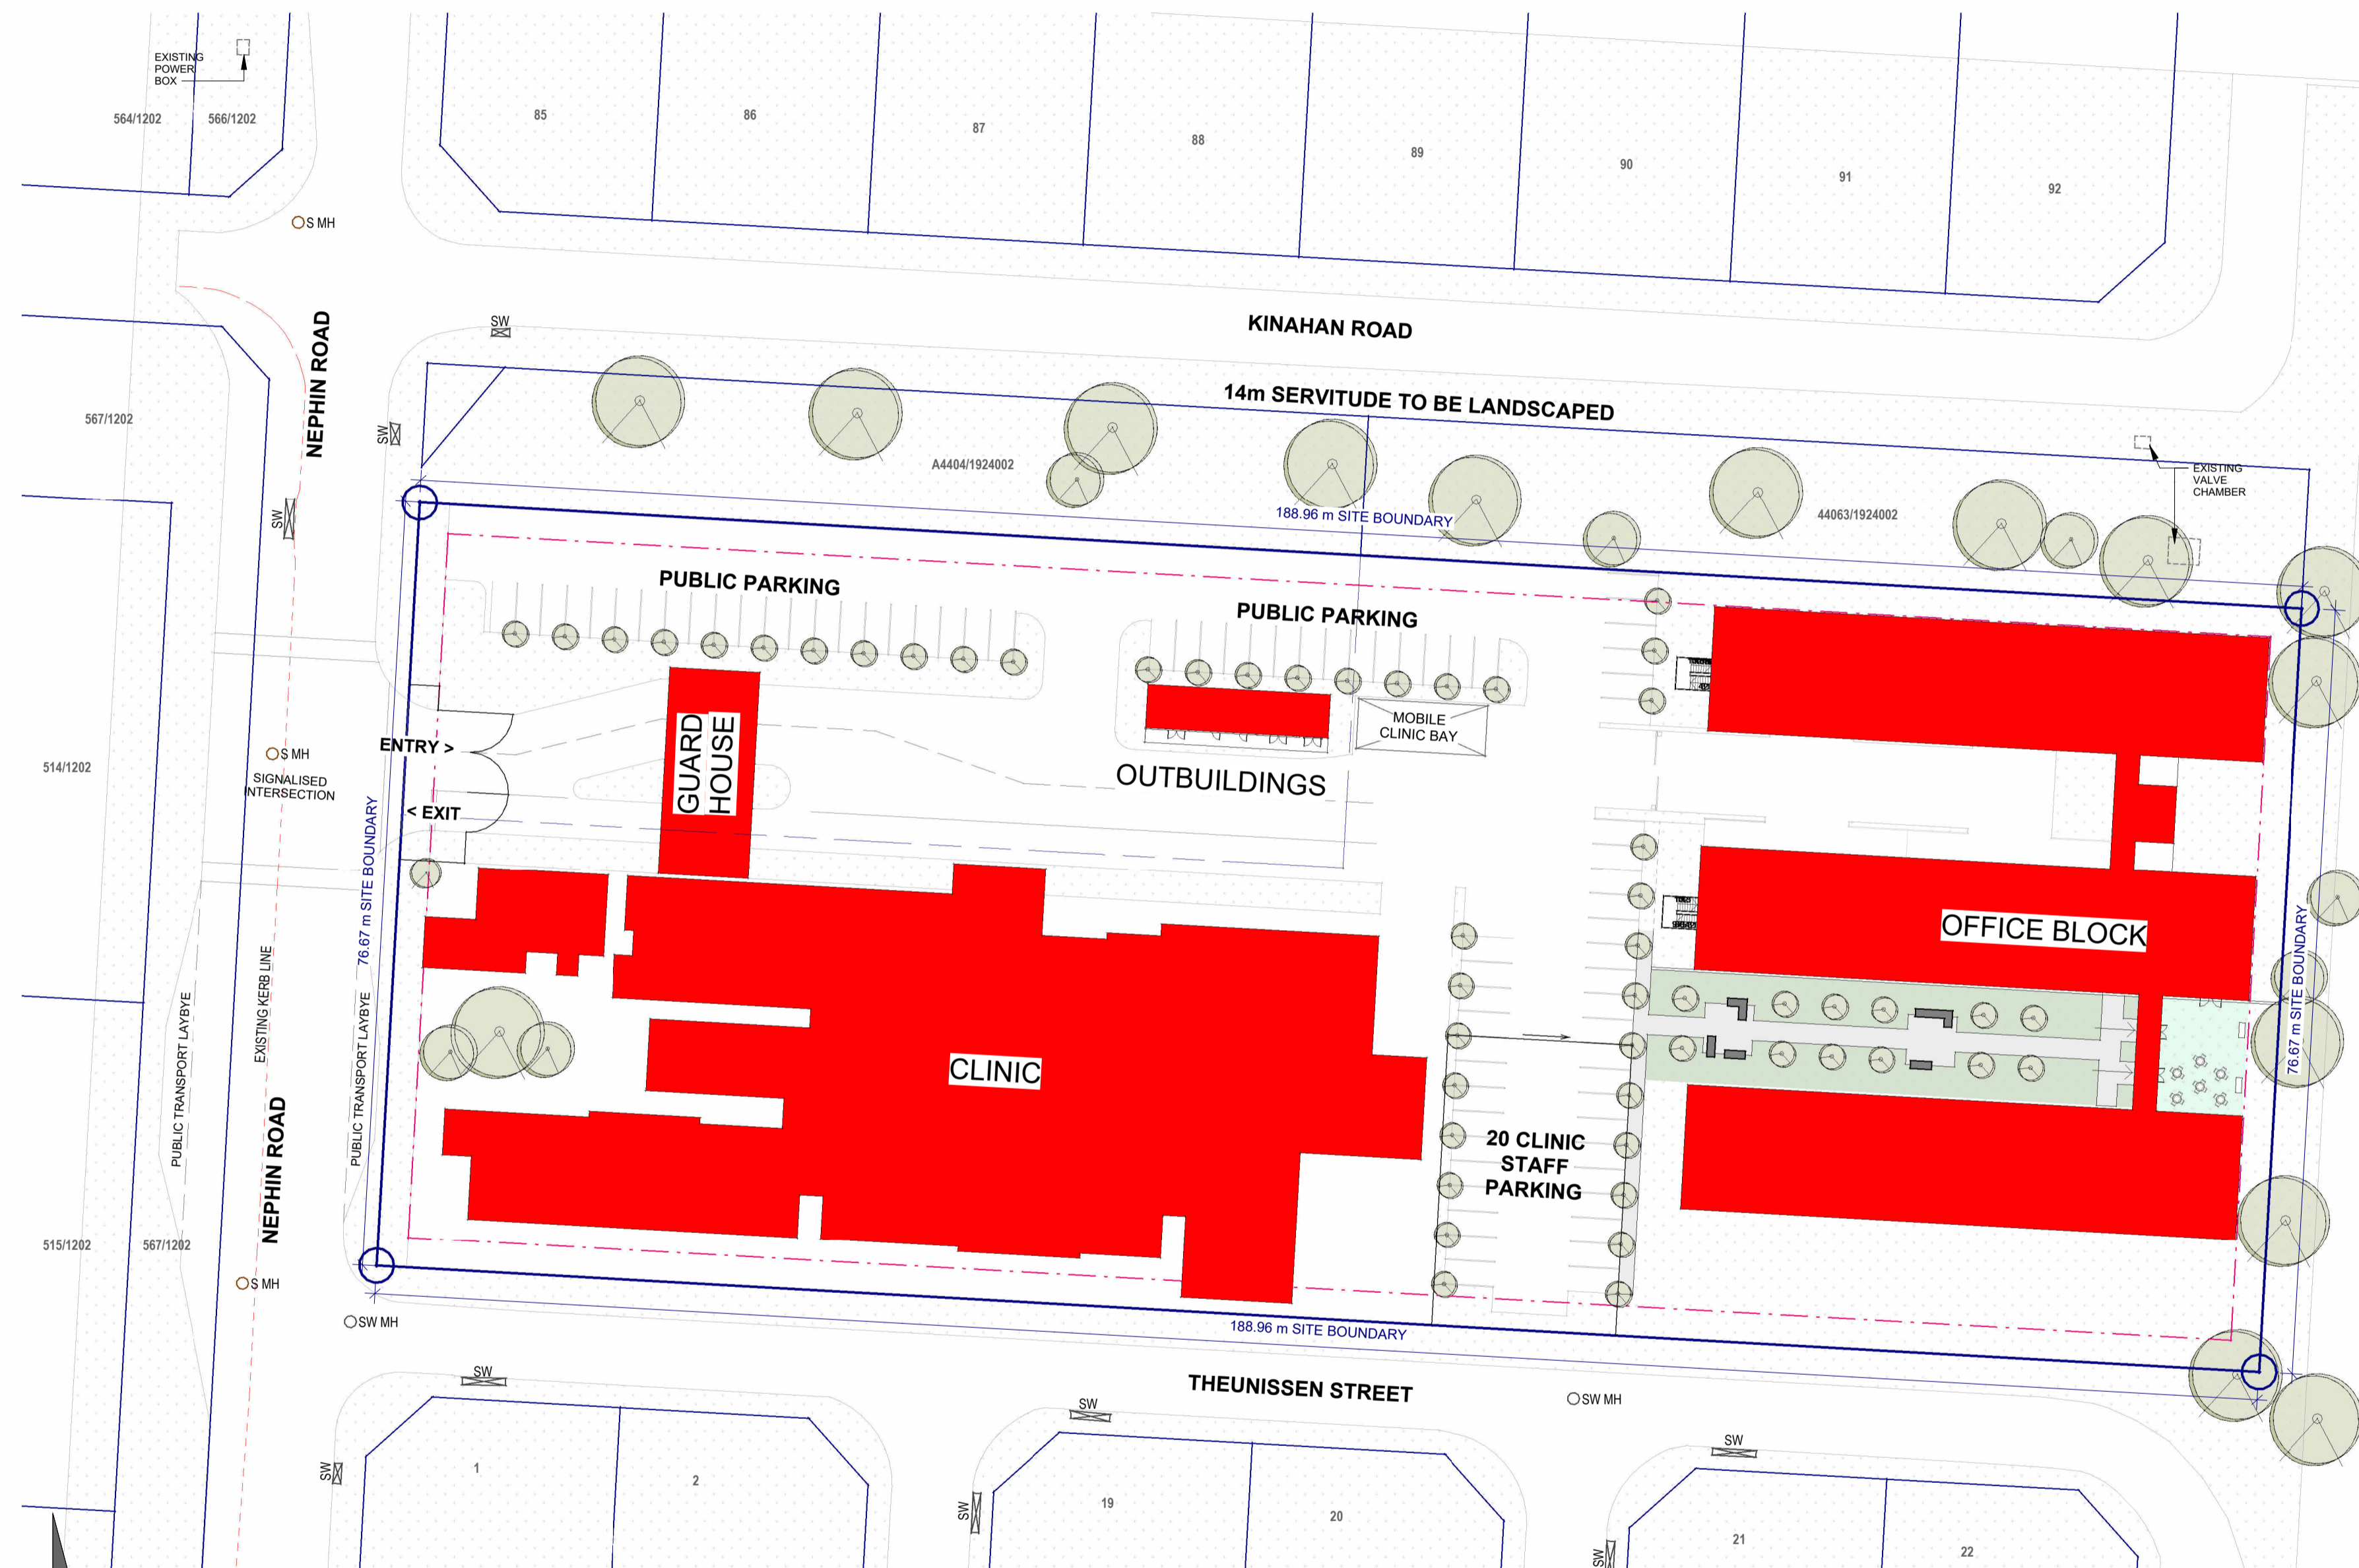

N **SITE PLAN**
1 : 500